


FIGURE 9.0

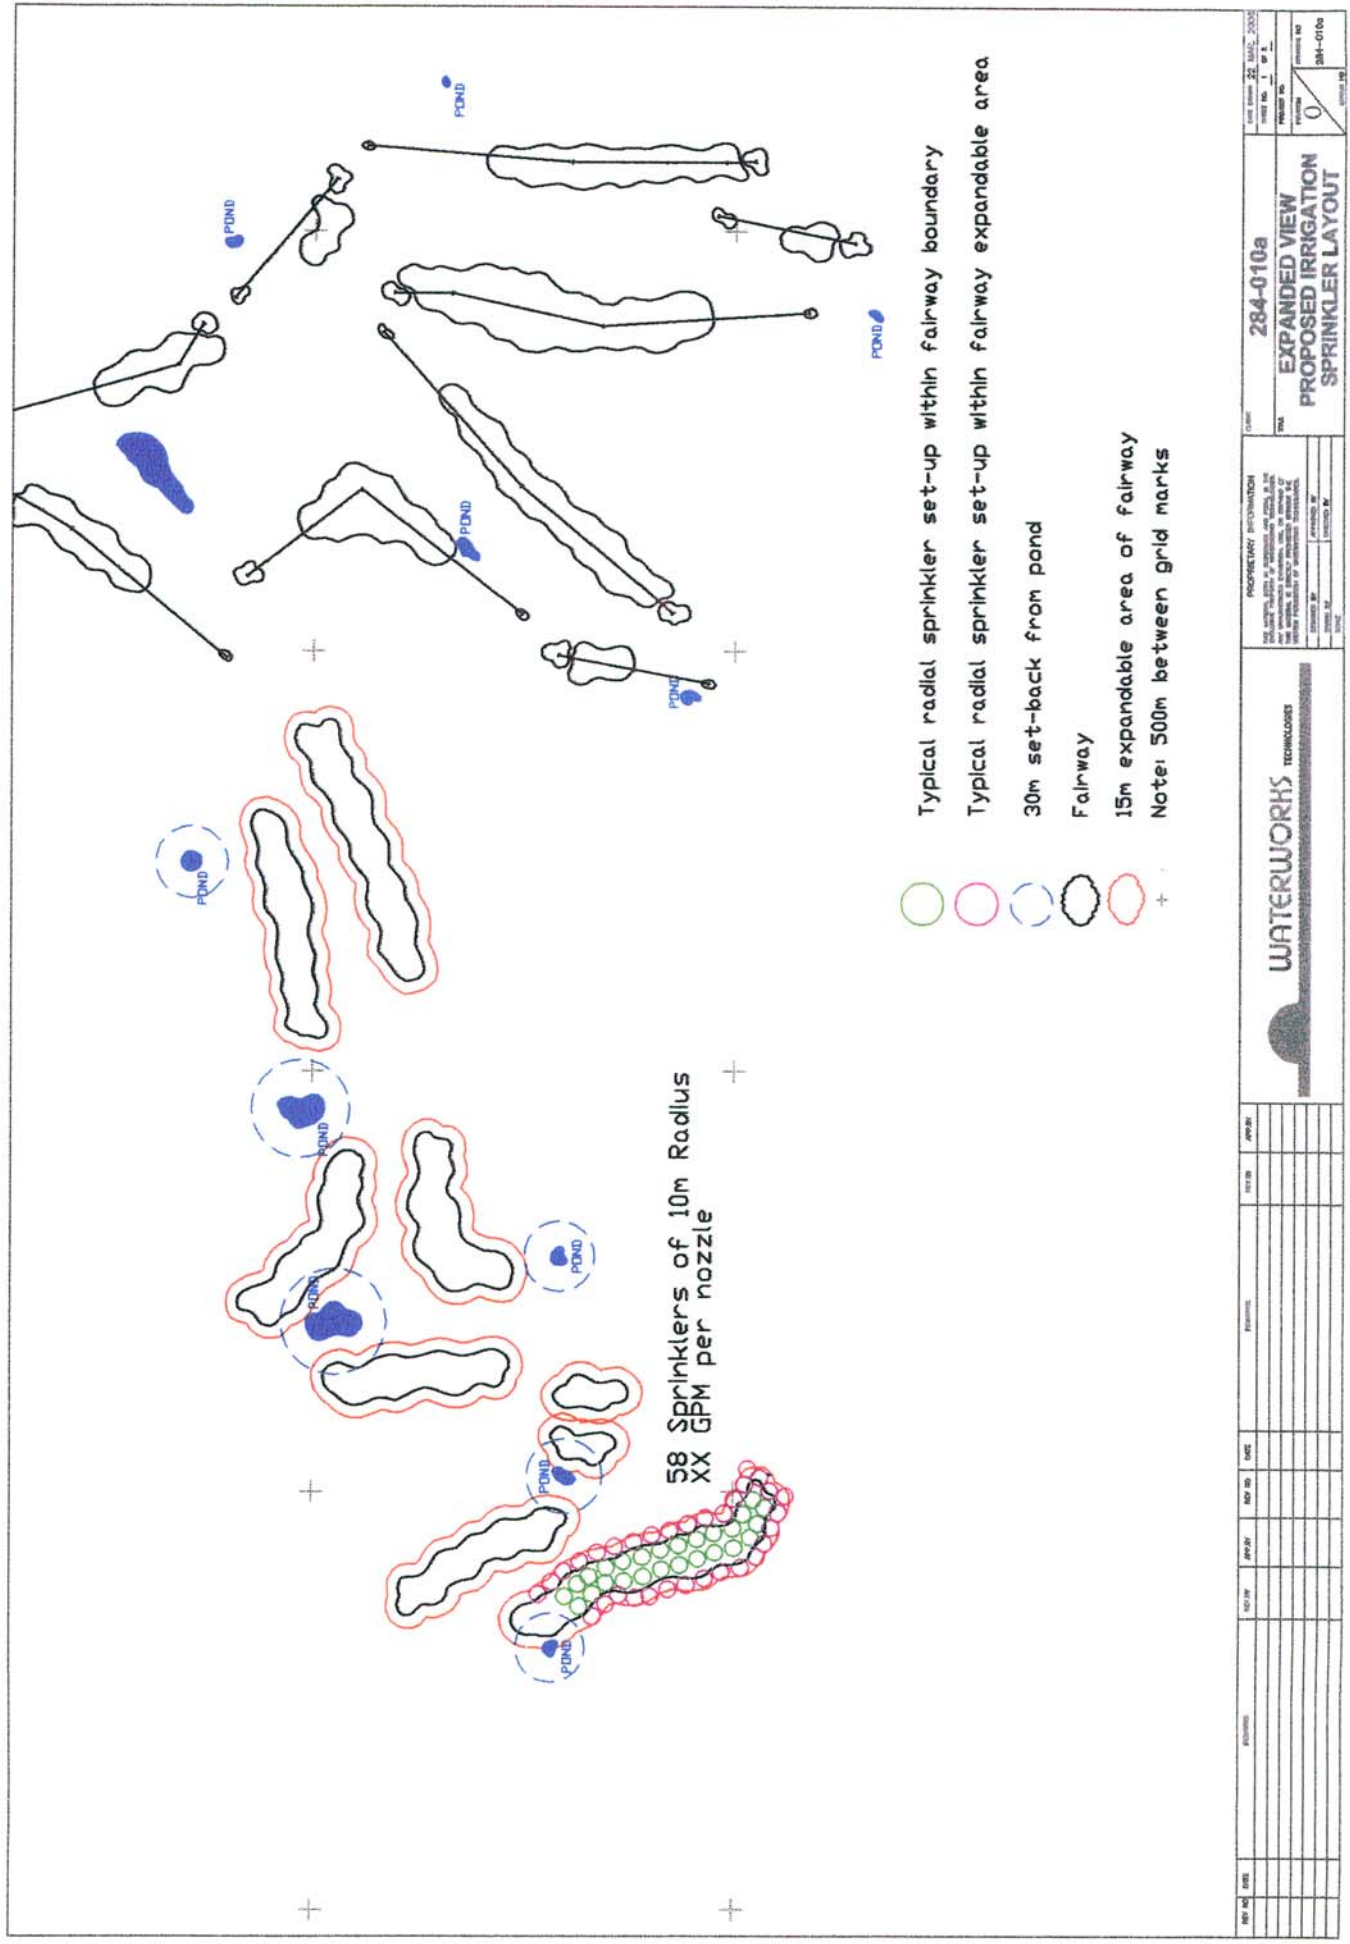

REV	DATE	DESCRIPTION	BY	CHECKED	DATE	PROJECT	NO.	DATE	SCALE	PROJECT NO.	DATE	SCALE
										284-010a EXPANDED VIEW PROPOSED IRRIGATION SPRINKLER LAYOUT		DATE: 22 MAR 2005 SHEET NO. 1 OF 1 PROJECT NO. 0 DRAWING NO. 284-010a SCALE:
PROPRIETARY INFORMATION THIS DOCUMENT IS THE PROPERTY OF WATERWORKS TECHNOLOGIES, INC. AND IS NOT TO BE REPRODUCED, COPIED, OR TRANSMITTED IN ANY FORM OR BY ANY MEANS, ELECTRONIC OR MECHANICAL, INCLUDING PHOTOCOPYING, RECORDING, OR BY ANY INFORMATION STORAGE AND RETRIEVAL SYSTEM, WITHOUT THE WRITTEN PERMISSION OF WATERWORKS TECHNOLOGIES, INC.												